 




REVISION DATE

ISSUE DATES		
TYPE	DATE	
OWNER REVIEW SET		
DRAWN BY	TA	
CHECKED BY	SA	
PROJECT NUMBER:		
X738800		
DATE:		
13 JAN, 2025		
SHEET TITLE:		



3 Elevation - Site 1
1 1/2" = 1' 0"




SPECIAL LATERALS
REPLACEMENT PHASE 18
Blosson Hills, Severna Park
Riviera, Beauty Beach, Green Haven,
REVISION DATE





[illegible]

ISSUE DATES		
TYPE	DATE	
OWNER REVIEW SET		
DRAWN BY	TA	
CHECKED BY	SA	
PROJECT NUMBER:		
X738800		
DATE:		
13 JAN, 2025		
SHEET TITLE:		

P102

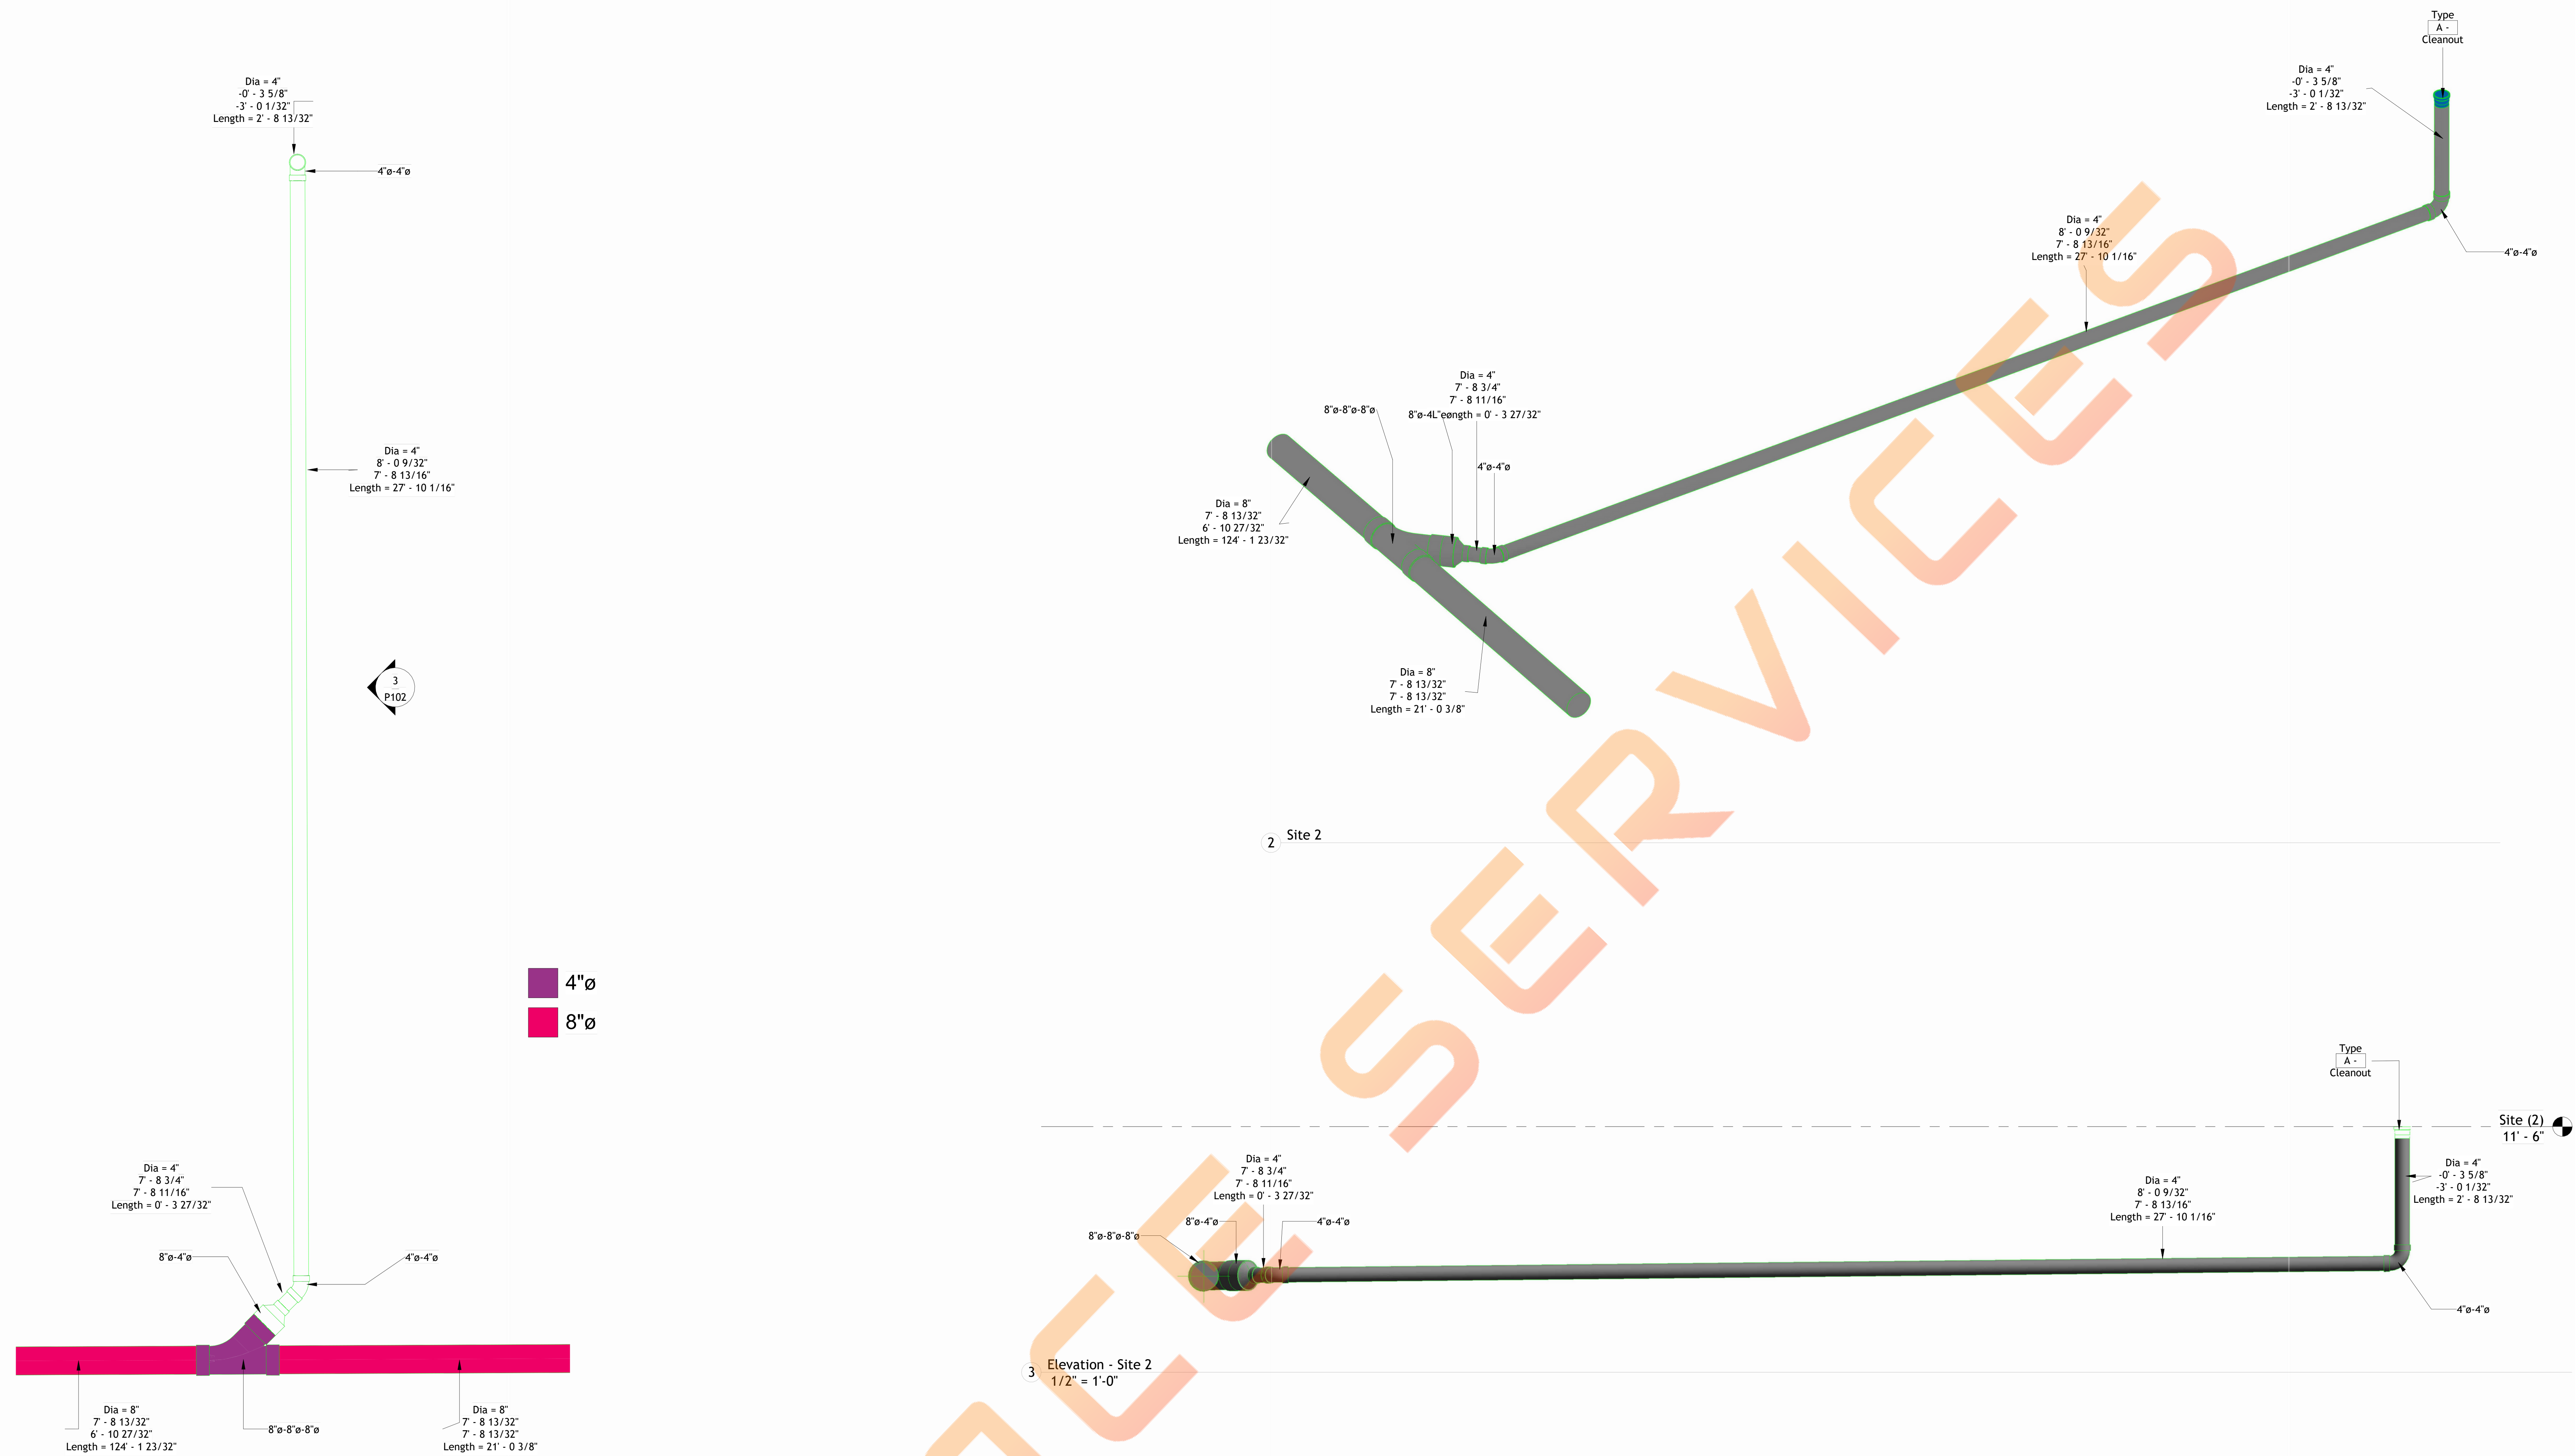

1 SITE 2 - Plumbing Plan
1/2" = 1'-0"

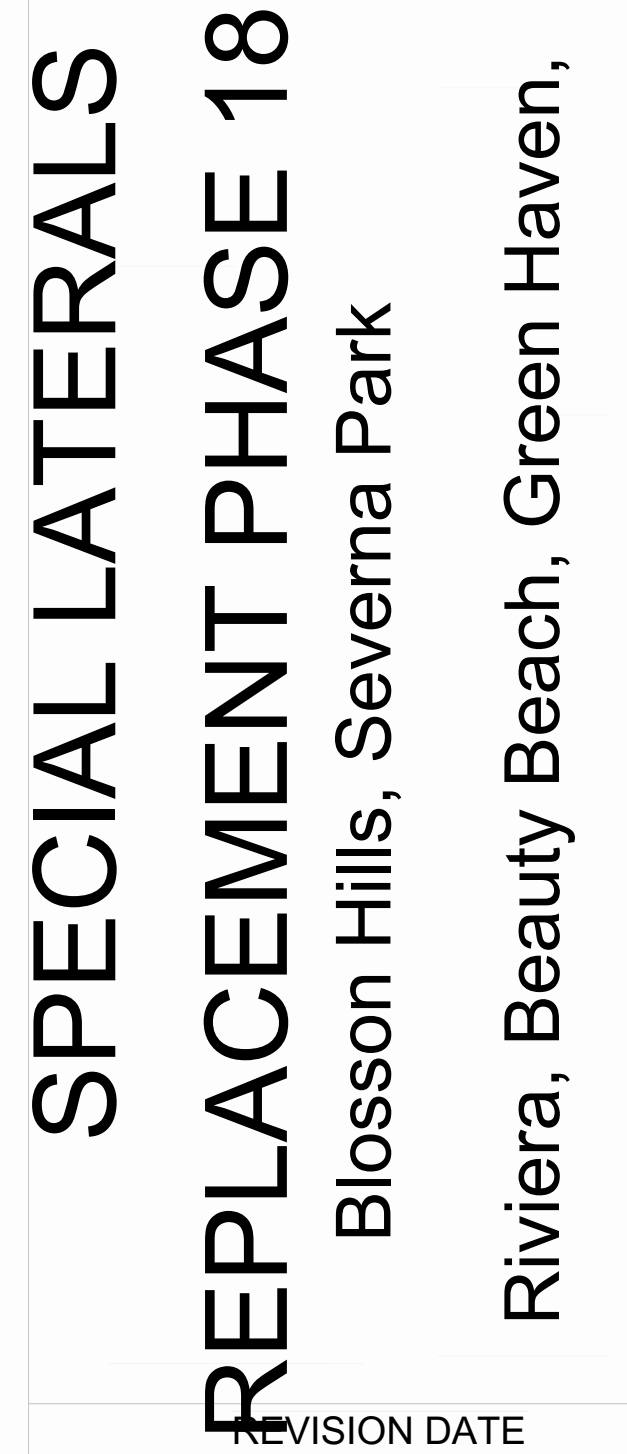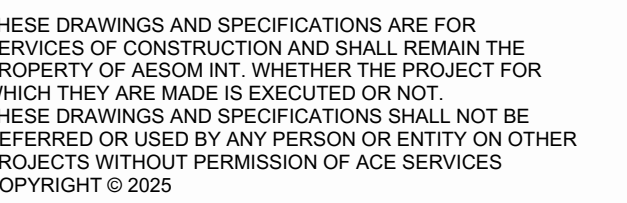  

ISSUE DATES		
TYPE	DATE	
OWNER REVIEW SET		
DRAWN BY	TA	
CHECKED BY	SA	
PROJECT NUMBER:		
X738800		
DATE:		
13 JAN, 2025		
SHEET TITLE:		

P103





Diagram of a 30' long, 4-inch diameter stormwater pipe with three manholes. The pipe has a 0.43% slope. The manholes are located at the following distances from the start of the pipe:

- Manhole 1: 5' 8 7/8' from the start
- Manhole 2: 5' from Manhole 1
- Manhole 3: 19' 1 1/2' from Manhole 2

The pipe's elevation at each manhole is shown as follows:


- Manhole 1: 21' - 2 15/32'
- Manhole 2: 21' - 2 1/2'
- Manhole 3: 21' - 2 15/32'

The ground surface elevation at the third manhole is 22' - 6".

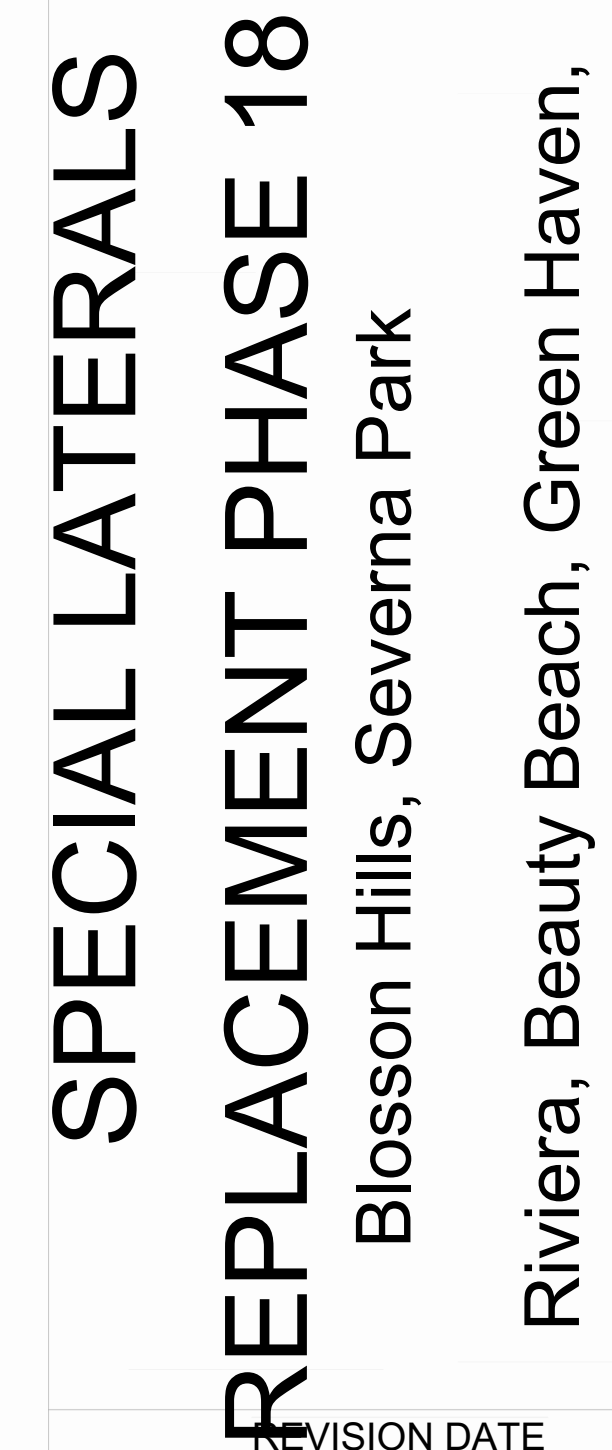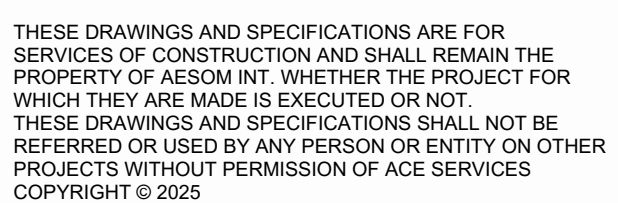

ISSUE DATES		
TYPE		DATE
OWNER REVIEW SET		
DRAWN BY	TA	
CHECKED BY	SA	
PROJECT NUMBER:		
X738800		
DATE:		
13 JAN, 2025		
SHEET TITLE:		

 P105



SPECIAL LATERALS
REPLACEMENT PHASE 18
Blossom Hills, Severna Park
Riviera, Beauty Beach, Green Haven,
REVISION DATE

[illegible]

P106



7901 4th St. N STE 300.
ST Petersburg, Florida 33702

VOICE: 281-899-0250

THESE DRAWINGS AND SPECIFICATIONS ARE FOR THE SERVICES OF CONSTRUCTION AND SHALL REMAIN THE PROPERTY OF AESOM INT. WHETHER THE PROJECT FOR WHICH THEY ARE MADE IS EXECUTED OR NOT.

THESE DRAWINGS AND SPECIFICATIONS SHALL NOT BE REPRODUCED OR USED BY ANY PERSON OR ENTITY ON OTHER PROJECTS WITHOUT PERMISSION OF ACE SERVICES

COPYRIGHT © 2025



SPECIAL LATERALS
REPLACEMENT PHASE 18
Blossom Hills, Severna Park
Riviera, Beauty Beach, Green Haven,
REVISION DATE

REVISION DATE

[illegible]

SUE DATES

PE	DATE
----	------


OWNER REVIEW SET

DRAWN BY	TA
CHECKED BY	SA
PROJECT NUMBER:	
X738800	
DATE:	
13 JAN, 2025	
SHEET TITLE:	


SITE 7 - Plumbing Plans

SHEET NUMBER:









P107

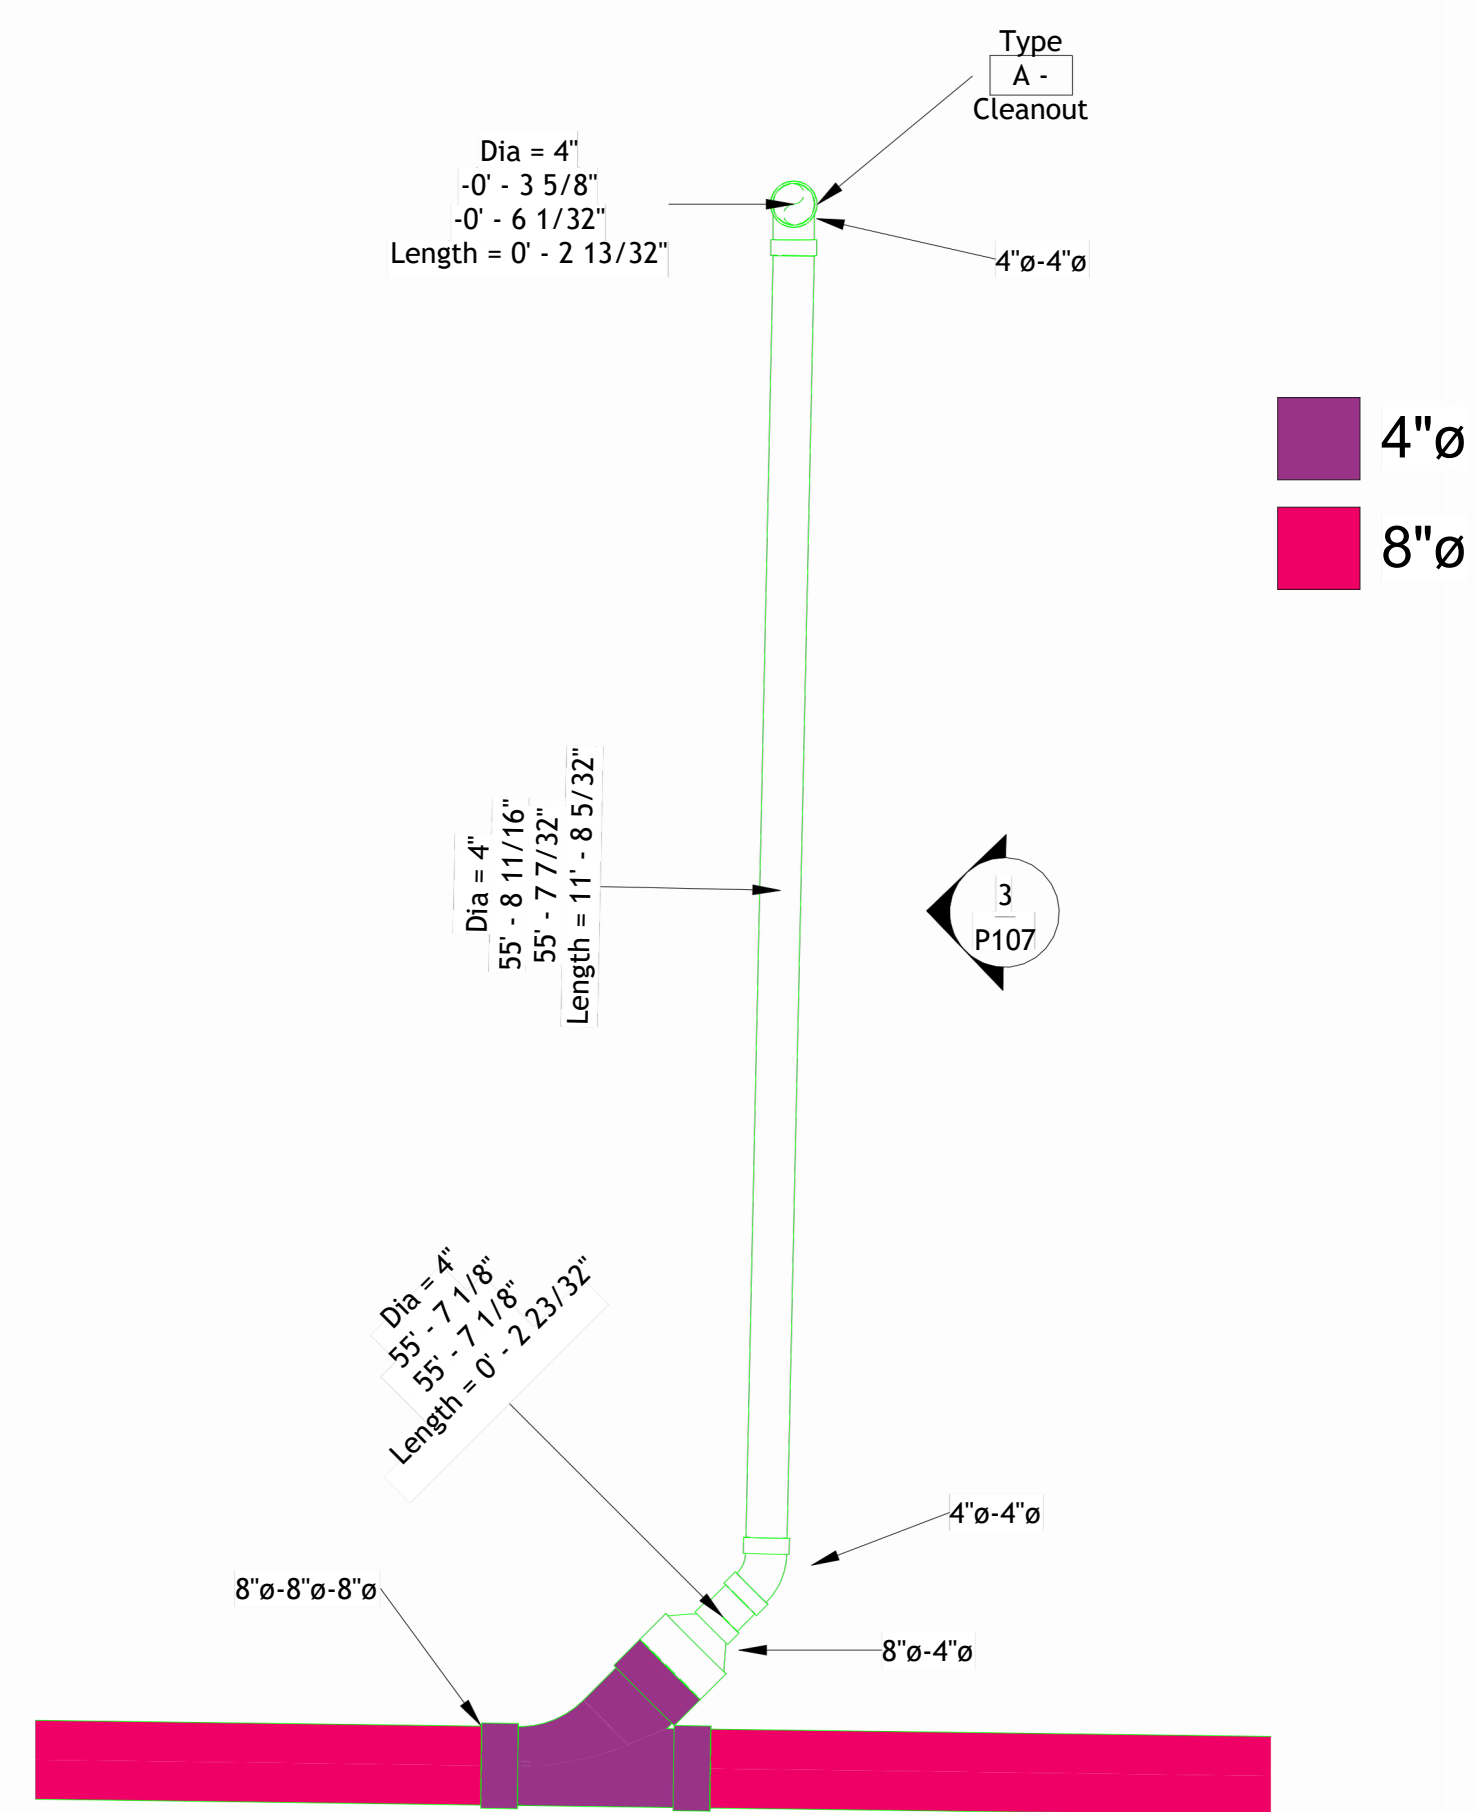

1 SITE 7 - Plumbing Plan
1/2" = 1'-0"

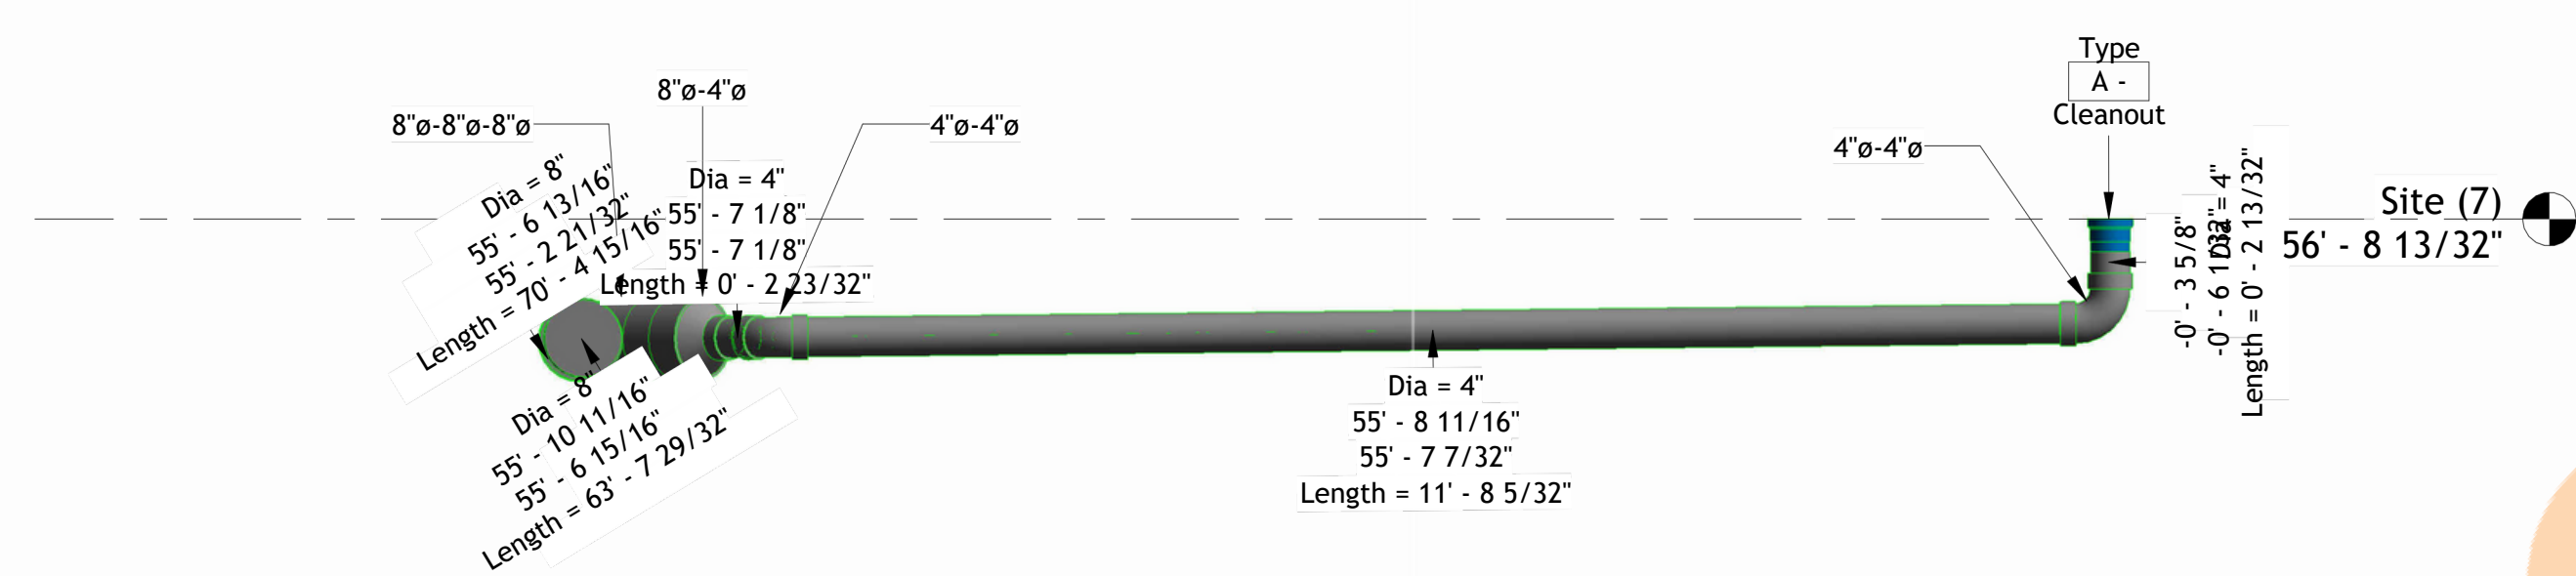

3 Elevation - Site 7
1/2" = 1'-0"

 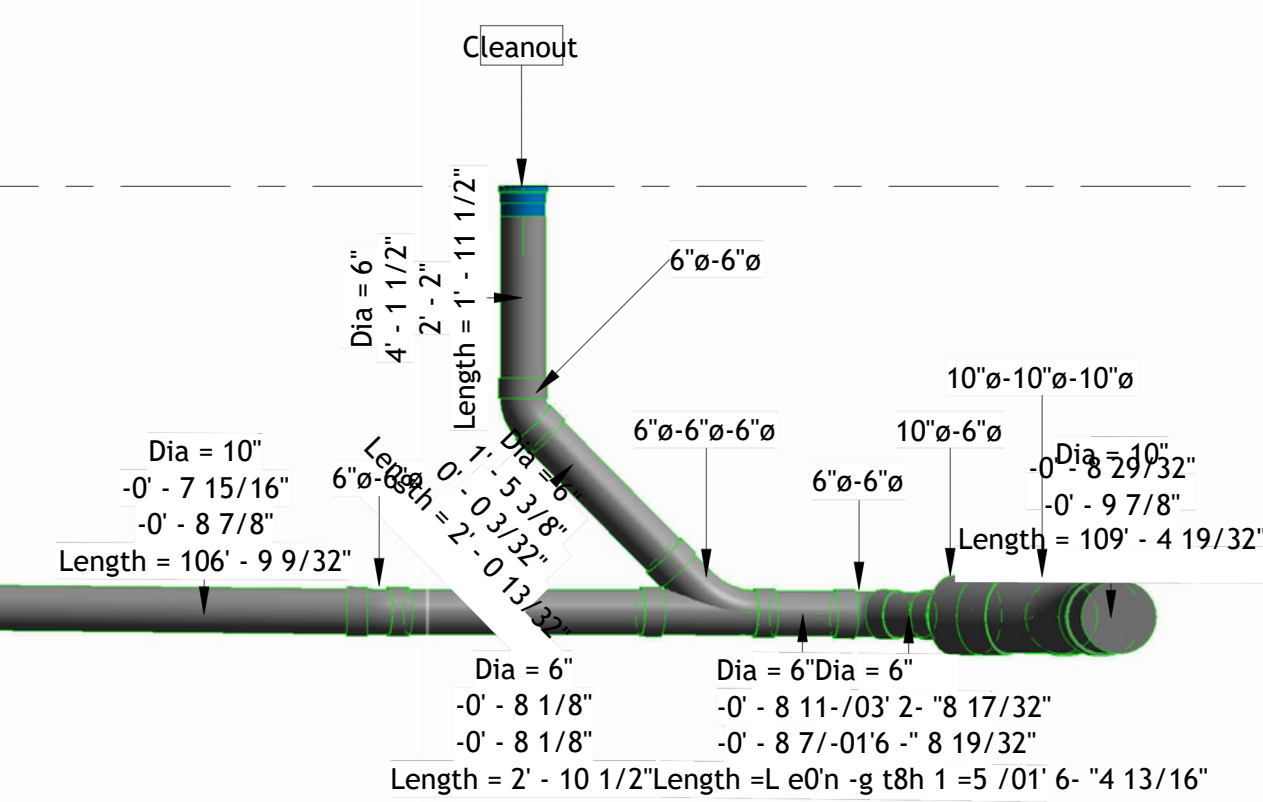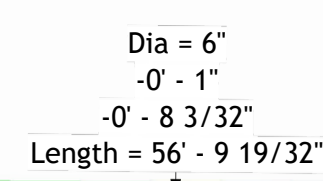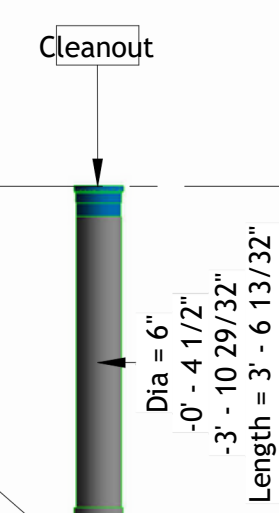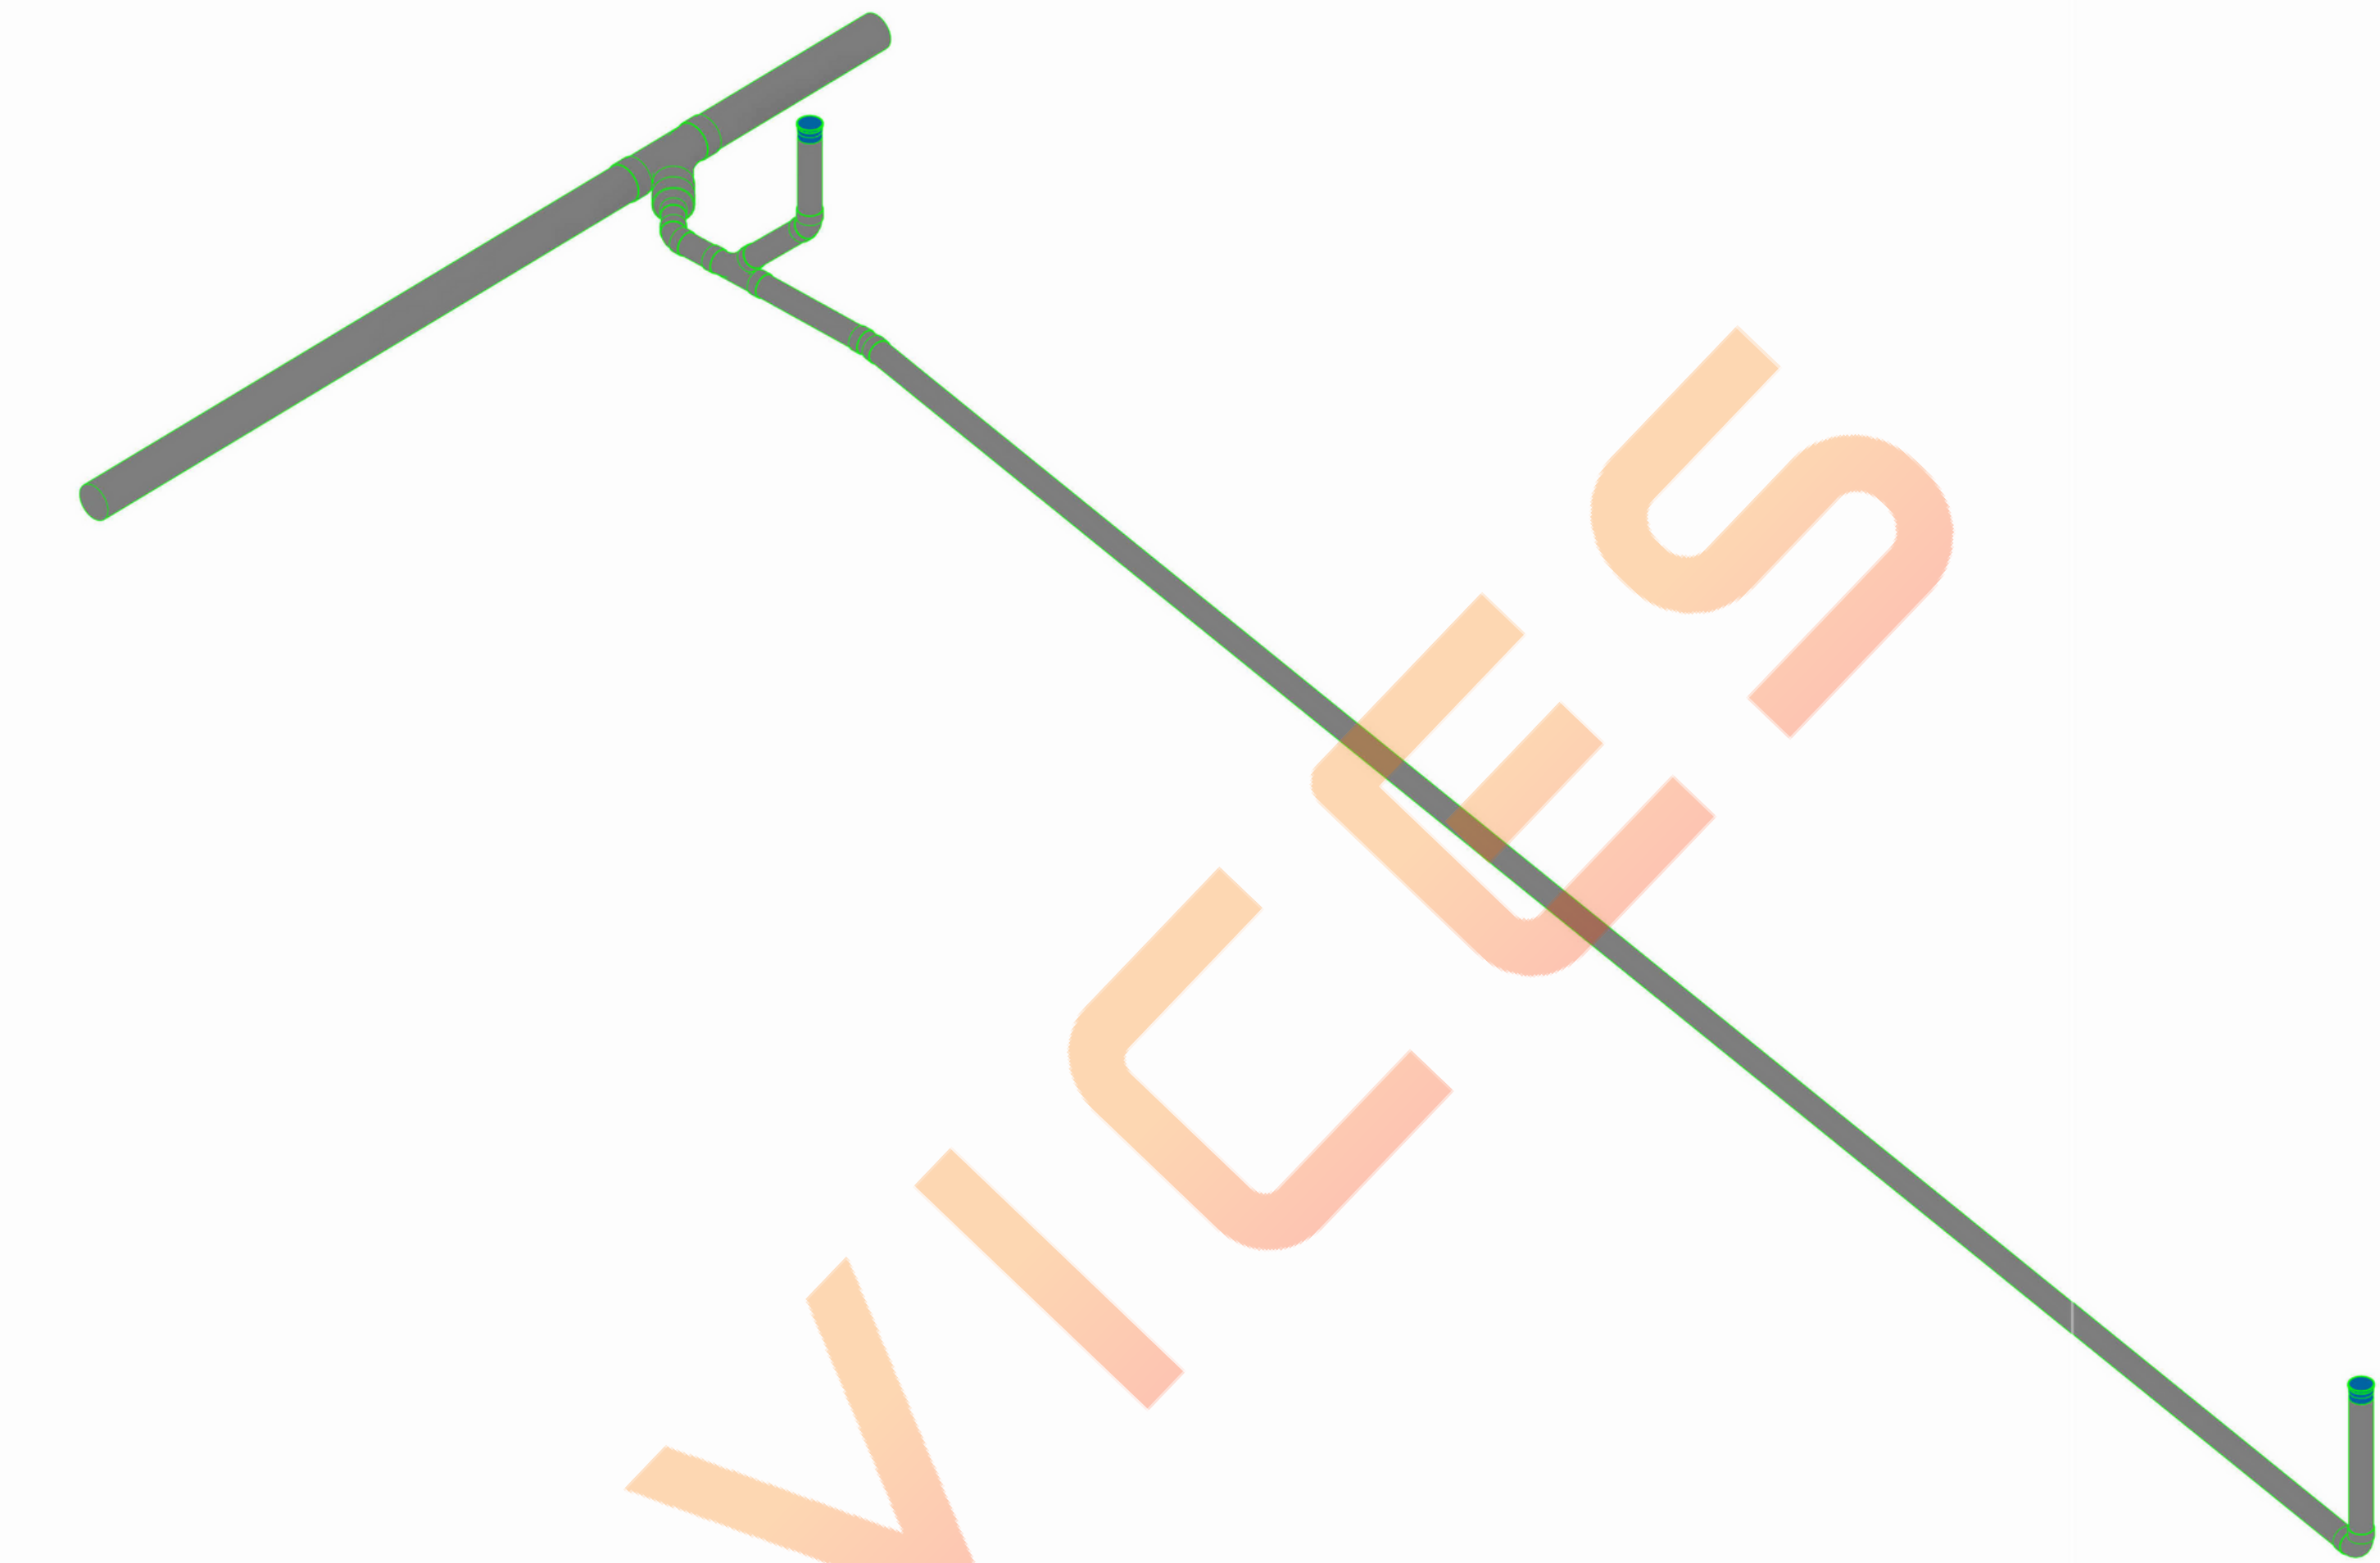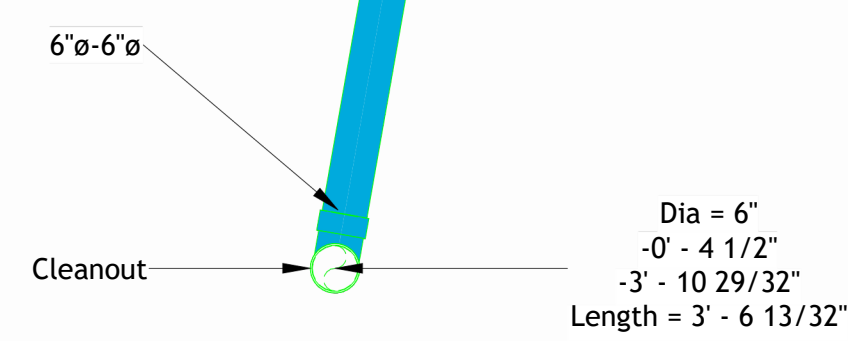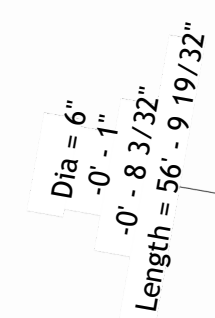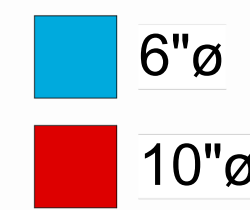

SPECIAL LATERALS REPLACEMENT PHASE 18

Blosson Hills, Severna Park
Riviera, Beauty Beach, Green Haven,

REVISION DATE

[illegible]

ISSUE DATES

TYPE	DATE
------	------

OWNER REVIEW SET

DRAWN BY	TA
----------	----

CHECKED BY	SA
------------	----

PROJECT NUMBER:
Y700000

X738800

DATE:

13 JAN, 2025
SHEET TITLE:

SITE 8 - Plumbing Plans

SHEET NUMBER: _____

P108

